


SEE TYPICAL FOR WASHER INSTALLATION
ALL FRESH WATER LINES ARE 1/2" UPONDR PEX
DRAINS ARE INSTALLED AT LOW POINTS
BELOW MAIN FLOOR=====

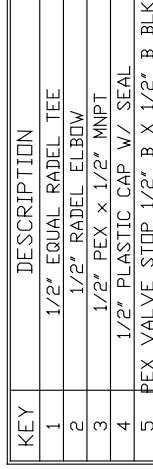


NEWMAR CORP P.O. Box 30, Nappanee, IN. 46550	Model: GS CA 3754	Sheet 2 OF 3	Drawn by: C. L.	Checked by: R. R.	Revision: ADD OPTIONAL ICE MAKER (ECO #787)	By: R. R.
Title: WATER LINES		I.D. # 2009\CA\CODE\PLUM\GS\3754	Date: 1/11/08	Date: 1/14/08		Date: 10/28/08
Title block-PB-TB-M7-KS						

NOTES:

- ALL PIPE & FITTINGS ARE ABS SCHED. #40
- ALL ELL'S ARE 90 LONG TURN UNLESS SPECIFIED
- ALL MATERIALS USED IN THE DRAINAGE SYSTEM CONFORM TO NFPA 1192 7.1.1
- DRAIN GRADE SET AT 1/8 INCH PER FOOT MINIMUM
- DRAIN LINES ARE SUPPORTED AT A MAXIMUM INTERVAL OF 4 FEET
- MAXIMUM TRAP ARM LENGTH IS 54"
- ALL TRAPS ARE A MINIMUM REQUIRED SIZE OF 1 1/4"
- ALL TANK HOOKUPS ARE A DOUBLE LTTY UNLESS SPECIFIED OTHERWISE
- IN OR BELOW MAIN FLOOR
- ALL CLEAN OUTS ARE 1 1/2" WYE'S
- SEE WASHER TYPICAL FOR WASHER PLUMBING
- TEI LISTED SWIVEL CONNECTIONS (LISTING #17062)
- ALL TRAPS ARE REMOVABLE FOR USE AS A CLEANOUT ACCESS
- * - DENOTES 1 1/2" CAF- FLEX

SIZE OF TRAP ARM (IN.)	DISTANCE FROM TRAP TO VENT (FT.)
1 1/4	4 1/2
1 1/2	4 1/2
2	5
3	6

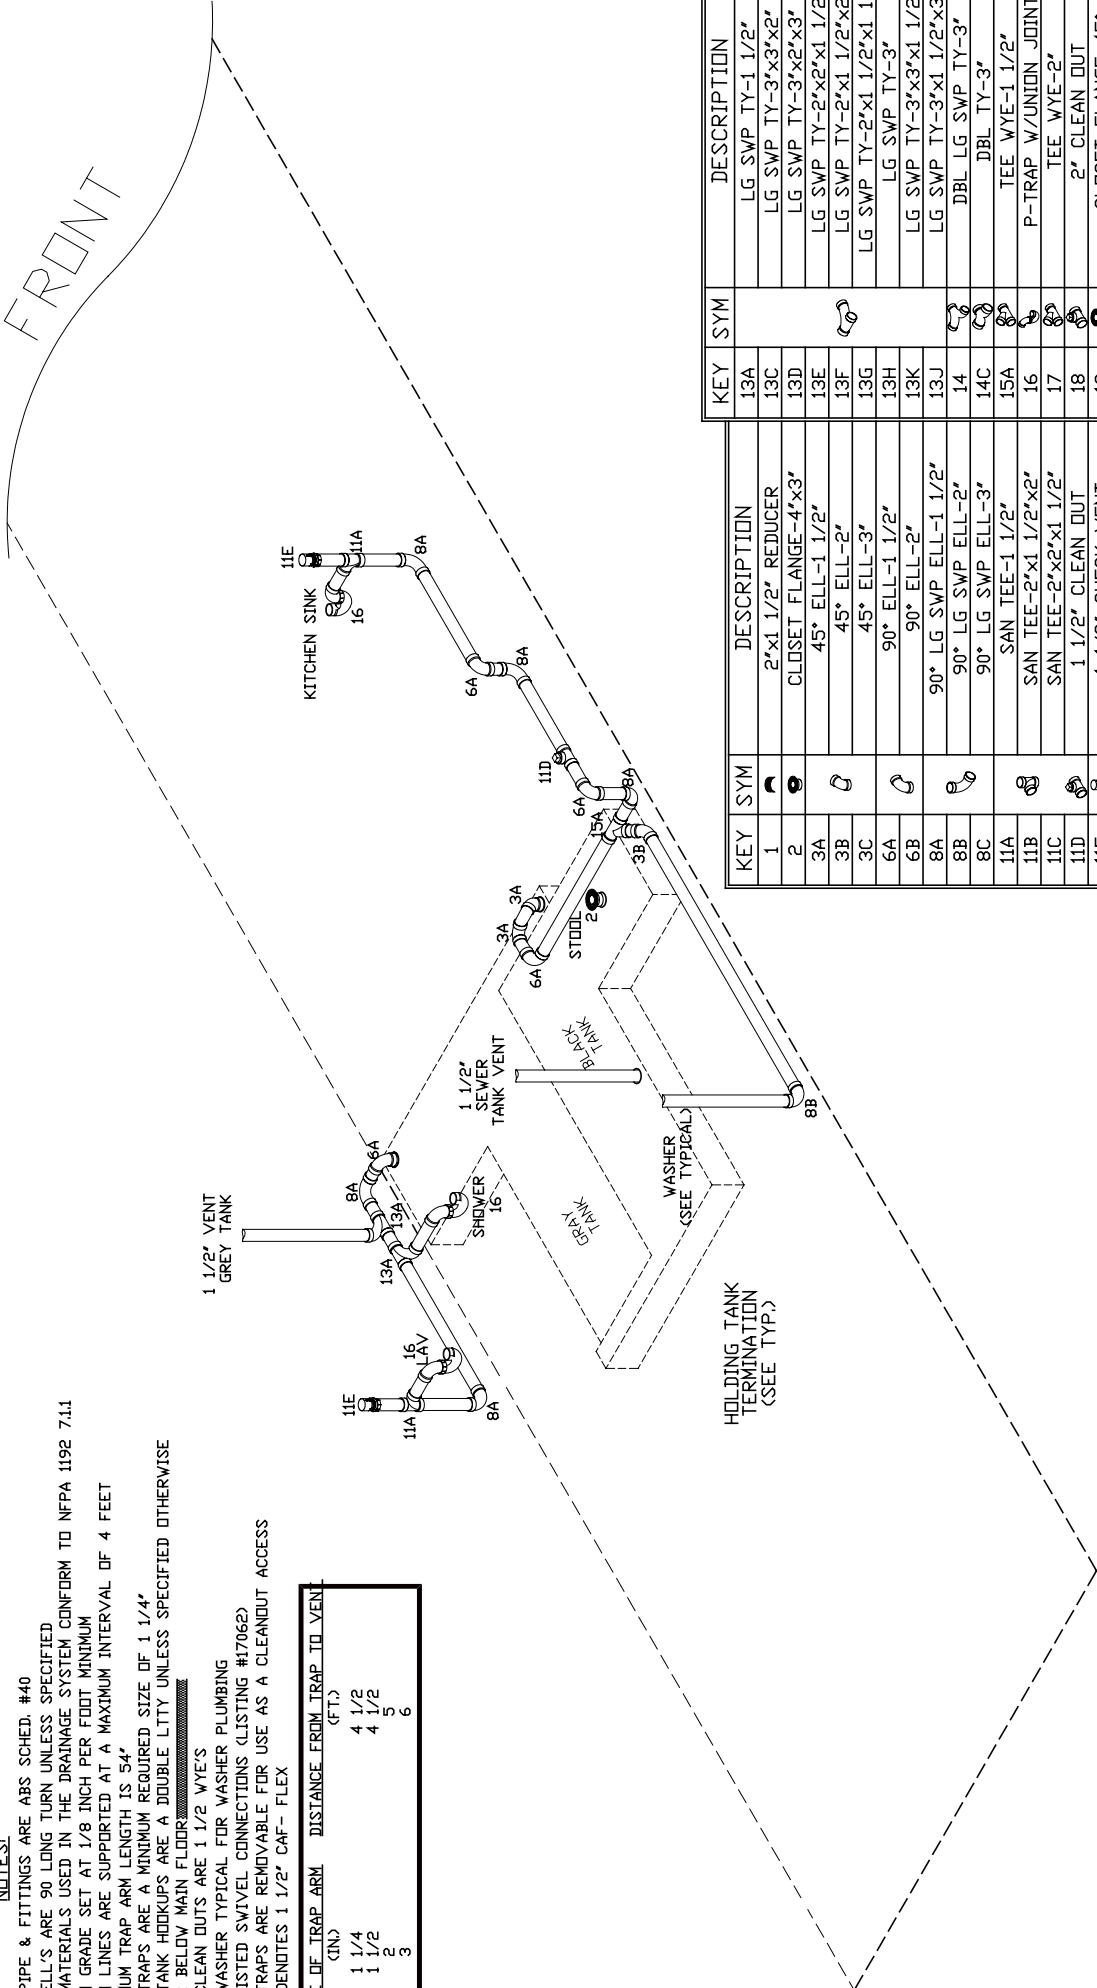

KEY	SYM	DESCRIPTION	KEY	SYM	DESCRIPTION
1		2"x1 1/2" REDUCER	13A		LG SWP TY-1 1/2"
2		CLOSET FLANGE-4"x3"	13C		LG SWP TY-3"x3"x2"
3A		45° ELL-1 1/2"	13D		LG SWP TY-3"x2"x3"
3B		45° ELL-2"	13E		LG SWP TY-2"x2"x1 1/2"
3C		45° ELL-3"	13F		LG SWP TY-2"x1 1/2"x2"
6A		90° ELL-1 1/2"	13G		LG SWP TY-2"x1 1/2"x1 1/2"
6B		90° ELL-2"	13H		LG SWP TY-3"
8A		90° LG SWP ELL-1 1/2"	13K		LG SWP TY-3"x3"x1 1/2"
8B		90° LG SWP ELL-2"	13J		LG SWP TY-3"x1 1/2"x3"
8C		90° LG SWP ELL-3"	14		DBL LG SWP TY-3"
11A		SAN TEE-1 1/2"	14C		DBL TY-3"
11B		SAN TEE-2"x1 1/2"x2"	15A		TEE WYE-1 1/2"
11C		SAN TEE-2"x2"x1 1/2"	16		P-TRAP W/UNION JOINT
11D		1 1/2" CLEAN OUT	17		TEE WYE-2"
11E		1 1/2" CHECK VENT	18		2" CLEAN OUT
			19		CLOSET FLANGE 45°

NEWMAR CORP P.O. Box 30, Nappanee, IN. 46550 Title block-PB_TB-M7_K3	Model: GS CA 3754	Sheet 3 OF 3	Drawn by: C. L.	Checked by: R. R.	Revision: CORRECTED ODS GREY VENT '13A' PLUMBING FIXTURE	By: C. L.		
						Date: 4/23/08		
			Title: DRAIN PLUMBING		Date: 1/11/08		By:	Date:
					Date: 1/14/08		By:	Date: